


- GENERAL NOTES:
- 1) ALL DOORS 3'-0" UNLESS OTHER WISE NOTED.
 - 2) DIMENSIONS ARE FOR INTERIOR REFERENCE ONLY, AND DO NOT REFLECT TOTAL SUITE SQUARE FOOTAGE.
 - 3) CEILING HEIGHTS ARE NOTED THROUGHOUT.
 - 4) CEILING MATERIAL -
STANDARD - 2'x4' DROP CEILING W/
2'x4' INLAY LIGHTING W/ GRID & VENTS.
 - 5) NO VISIBLE SIGN OF SPRINKLER SYSTEM.
- ELECTRICAL PANEL INFORMATION:
EPI-CAT 0004000223 TYPE I ENCLOSURE
SERIES L4 NO OTHER INFORMATION AVAILABLE

⊗	COMBINATION EXIT SIGN AND EMERGENCY BATTER LIGHT, NUMBER OF HEADS INDICATED, WALL OR CEILING MOUNTED.	⌈	F.F. FINISH FLOOR
⬆	EMERGENCY LIGHTS	⌋	TELEPHONE JACK
⊙	EXIT LIGHT	⊖	DUPPLICATE OUTLET
⦿	FIRE EXTINGUISHER	⊕	QUAD OUTLET

HATCH PATTERNS:

	BRICK
	CONCRETE

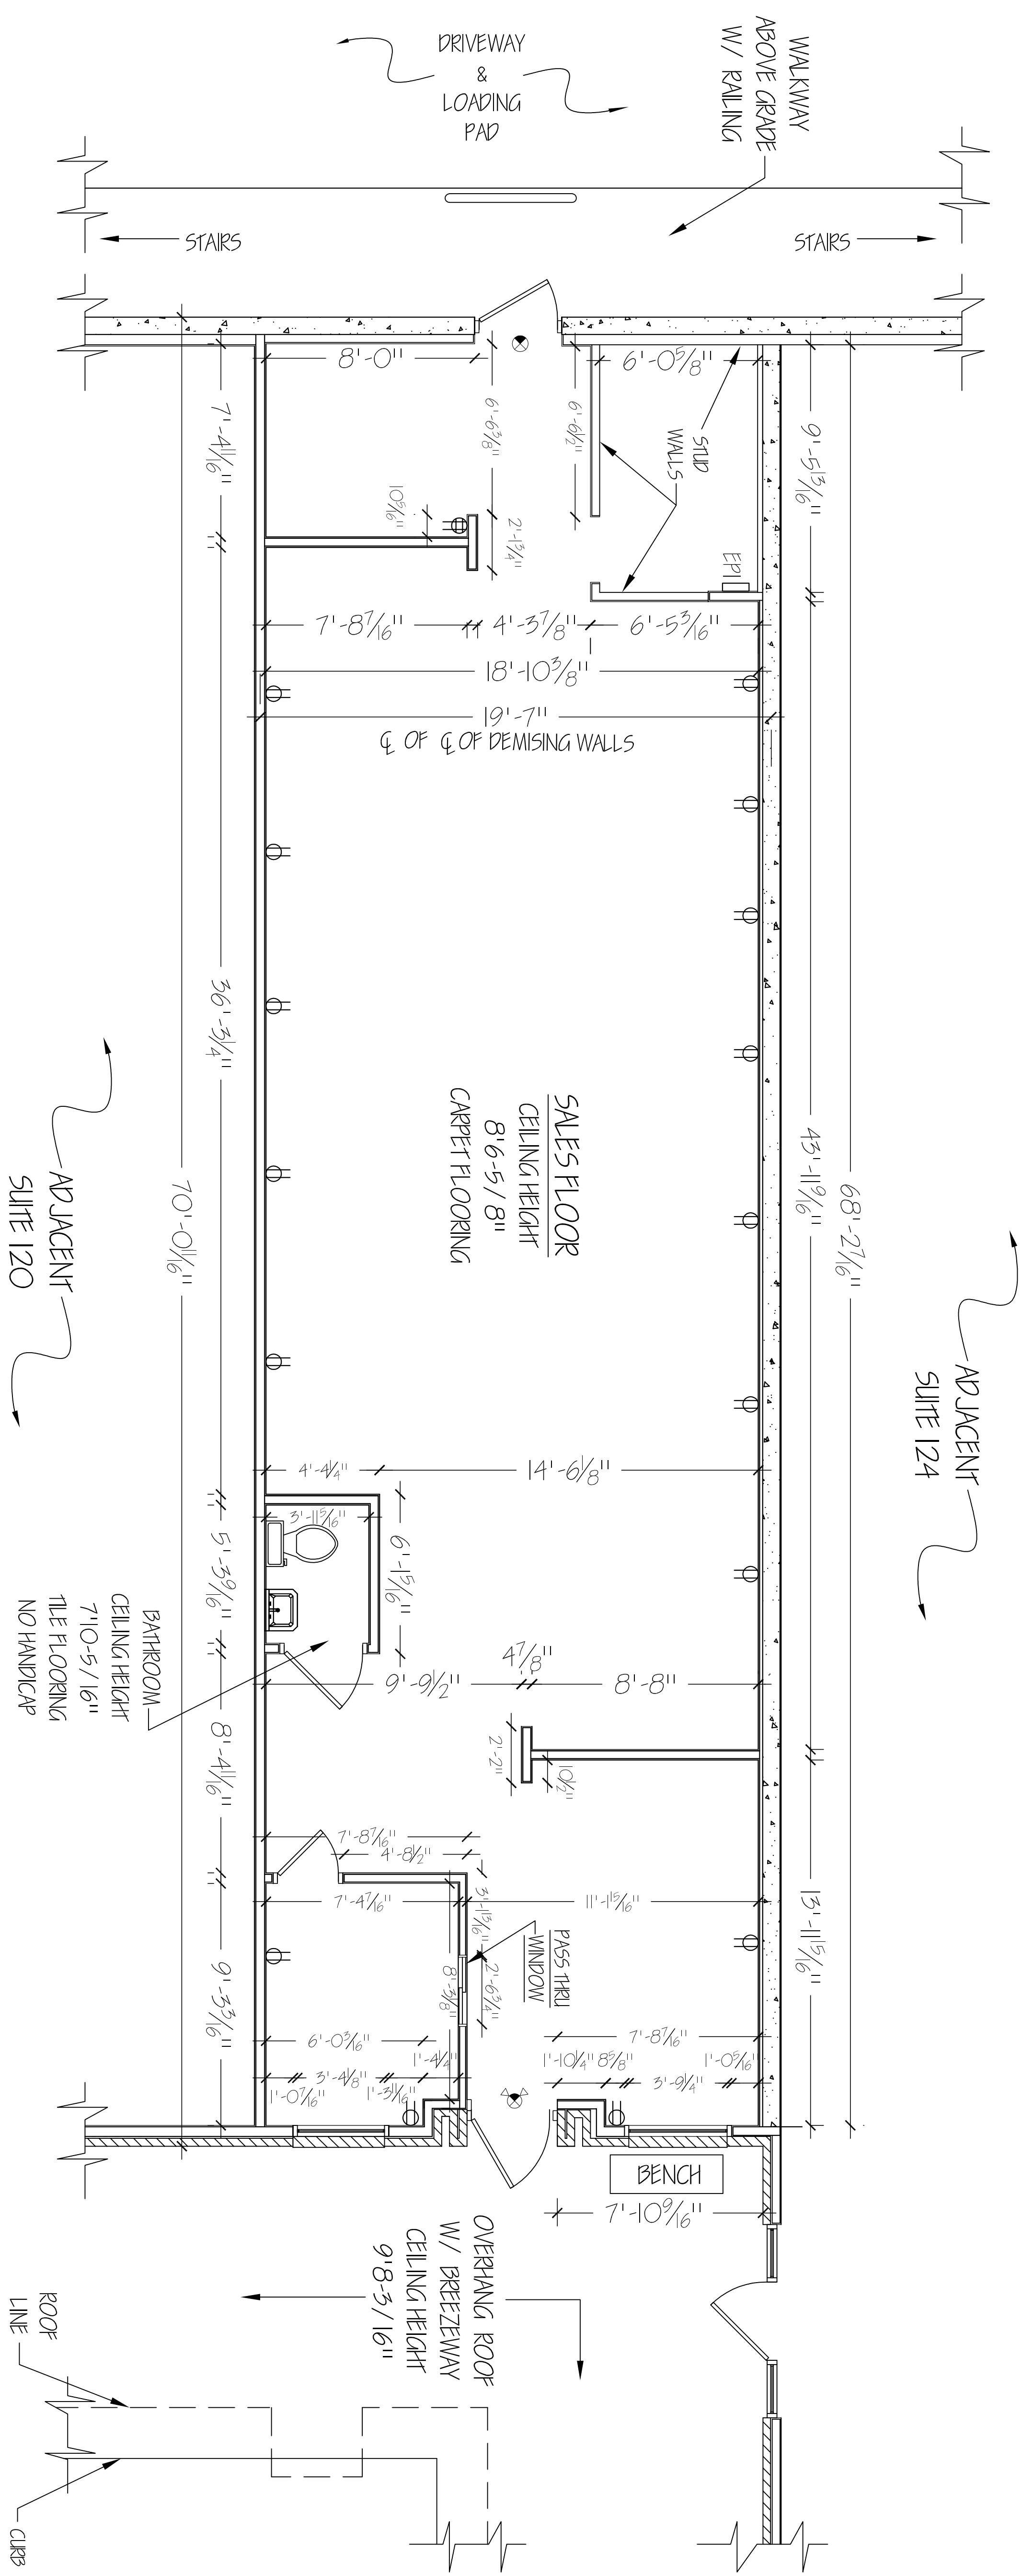

DESIGN MIMMS
DRAWN MIMMS
CHECKED MIMMS
DATE 11/27/2010
SCALE AS SHOWN
JOB NO. MIMMS001
SHEET A-1

FLOOR PLAN

ARCHITECTURAL
ILLUSTRATION & DESIGN
507 TREE CORNERS PARKWAY
NORCROSS, GA 30092
770-364-7559 reingore2003@yahoo.com

MARKET SQUARE SHOPPING CENTER
SUITE 122
102-180 MARKET SQUARE
CARTERVILLE, GA 30120

MALON D MIMMS CO
85-A MILL ST.
ROSWELL, GA 30075
770-518-1100

