


|                                                                                                                                                                                                                                                                                                                                                                                                                                                                                                                                                                                     |  |
|-------------------------------------------------------------------------------------------------------------------------------------------------------------------------------------------------------------------------------------------------------------------------------------------------------------------------------------------------------------------------------------------------------------------------------------------------------------------------------------------------------------------------------------------------------------------------------------|--|
| GENERAL NOTES:<br>1) ALL DOORS 3'-0" UNLESS OTHER WISE NOTED.<br>2) DIMENSIONS ARE FOR INTERIOR REFERENCE ONLY, AND DO NOT REFLECT TOTAL SUITE SQUARE FOOTAGE.<br>3) CEILING HEIGHT 5 ARE NOTED THROUGHOUT.<br>4) CEILING MATERIAL - STANDARD 2'x4' DROP CEILING W/ INLAY LIGHTING W/ GRID & VENTS.<br>5) NO VISIBLE SIGN OF SPRINKLER SYSTEM, ELECTRICAL PANEL INFORMATION:<br>EP1-400A/ 600V CIR. BRK.<br>EP2-100A/ 240V CIR. BRK.<br>EP3-60A/ 240V CIR. BRK.<br>EP4-50A/ 240V CIR. BRK.<br>EP5-200A, 120/ 208V ELEC. SUBPANEL<br>WATER HEATER INFO-<br>120 GAL. GAS WATER HEATER |  |
| COMBINATION EXIT SIGN AND EMERGENCY BATTER LIGHT, NUMBER OF HEADS INDICATED, WALL OR CEILING MOUNTED.<br>EMERGENCY LIGHTS<br>EXIT LIGHT<br>FIRE EXTINGUISHER                                                                                                                                                                                                                                                                                                                                                                                                                        |  |
| HATCH PATTERNS:<br>BRICK<br>CONCRETE                                                                                                                                                                                                                                                                                                                                                                                                                                                                                                                                                |  |

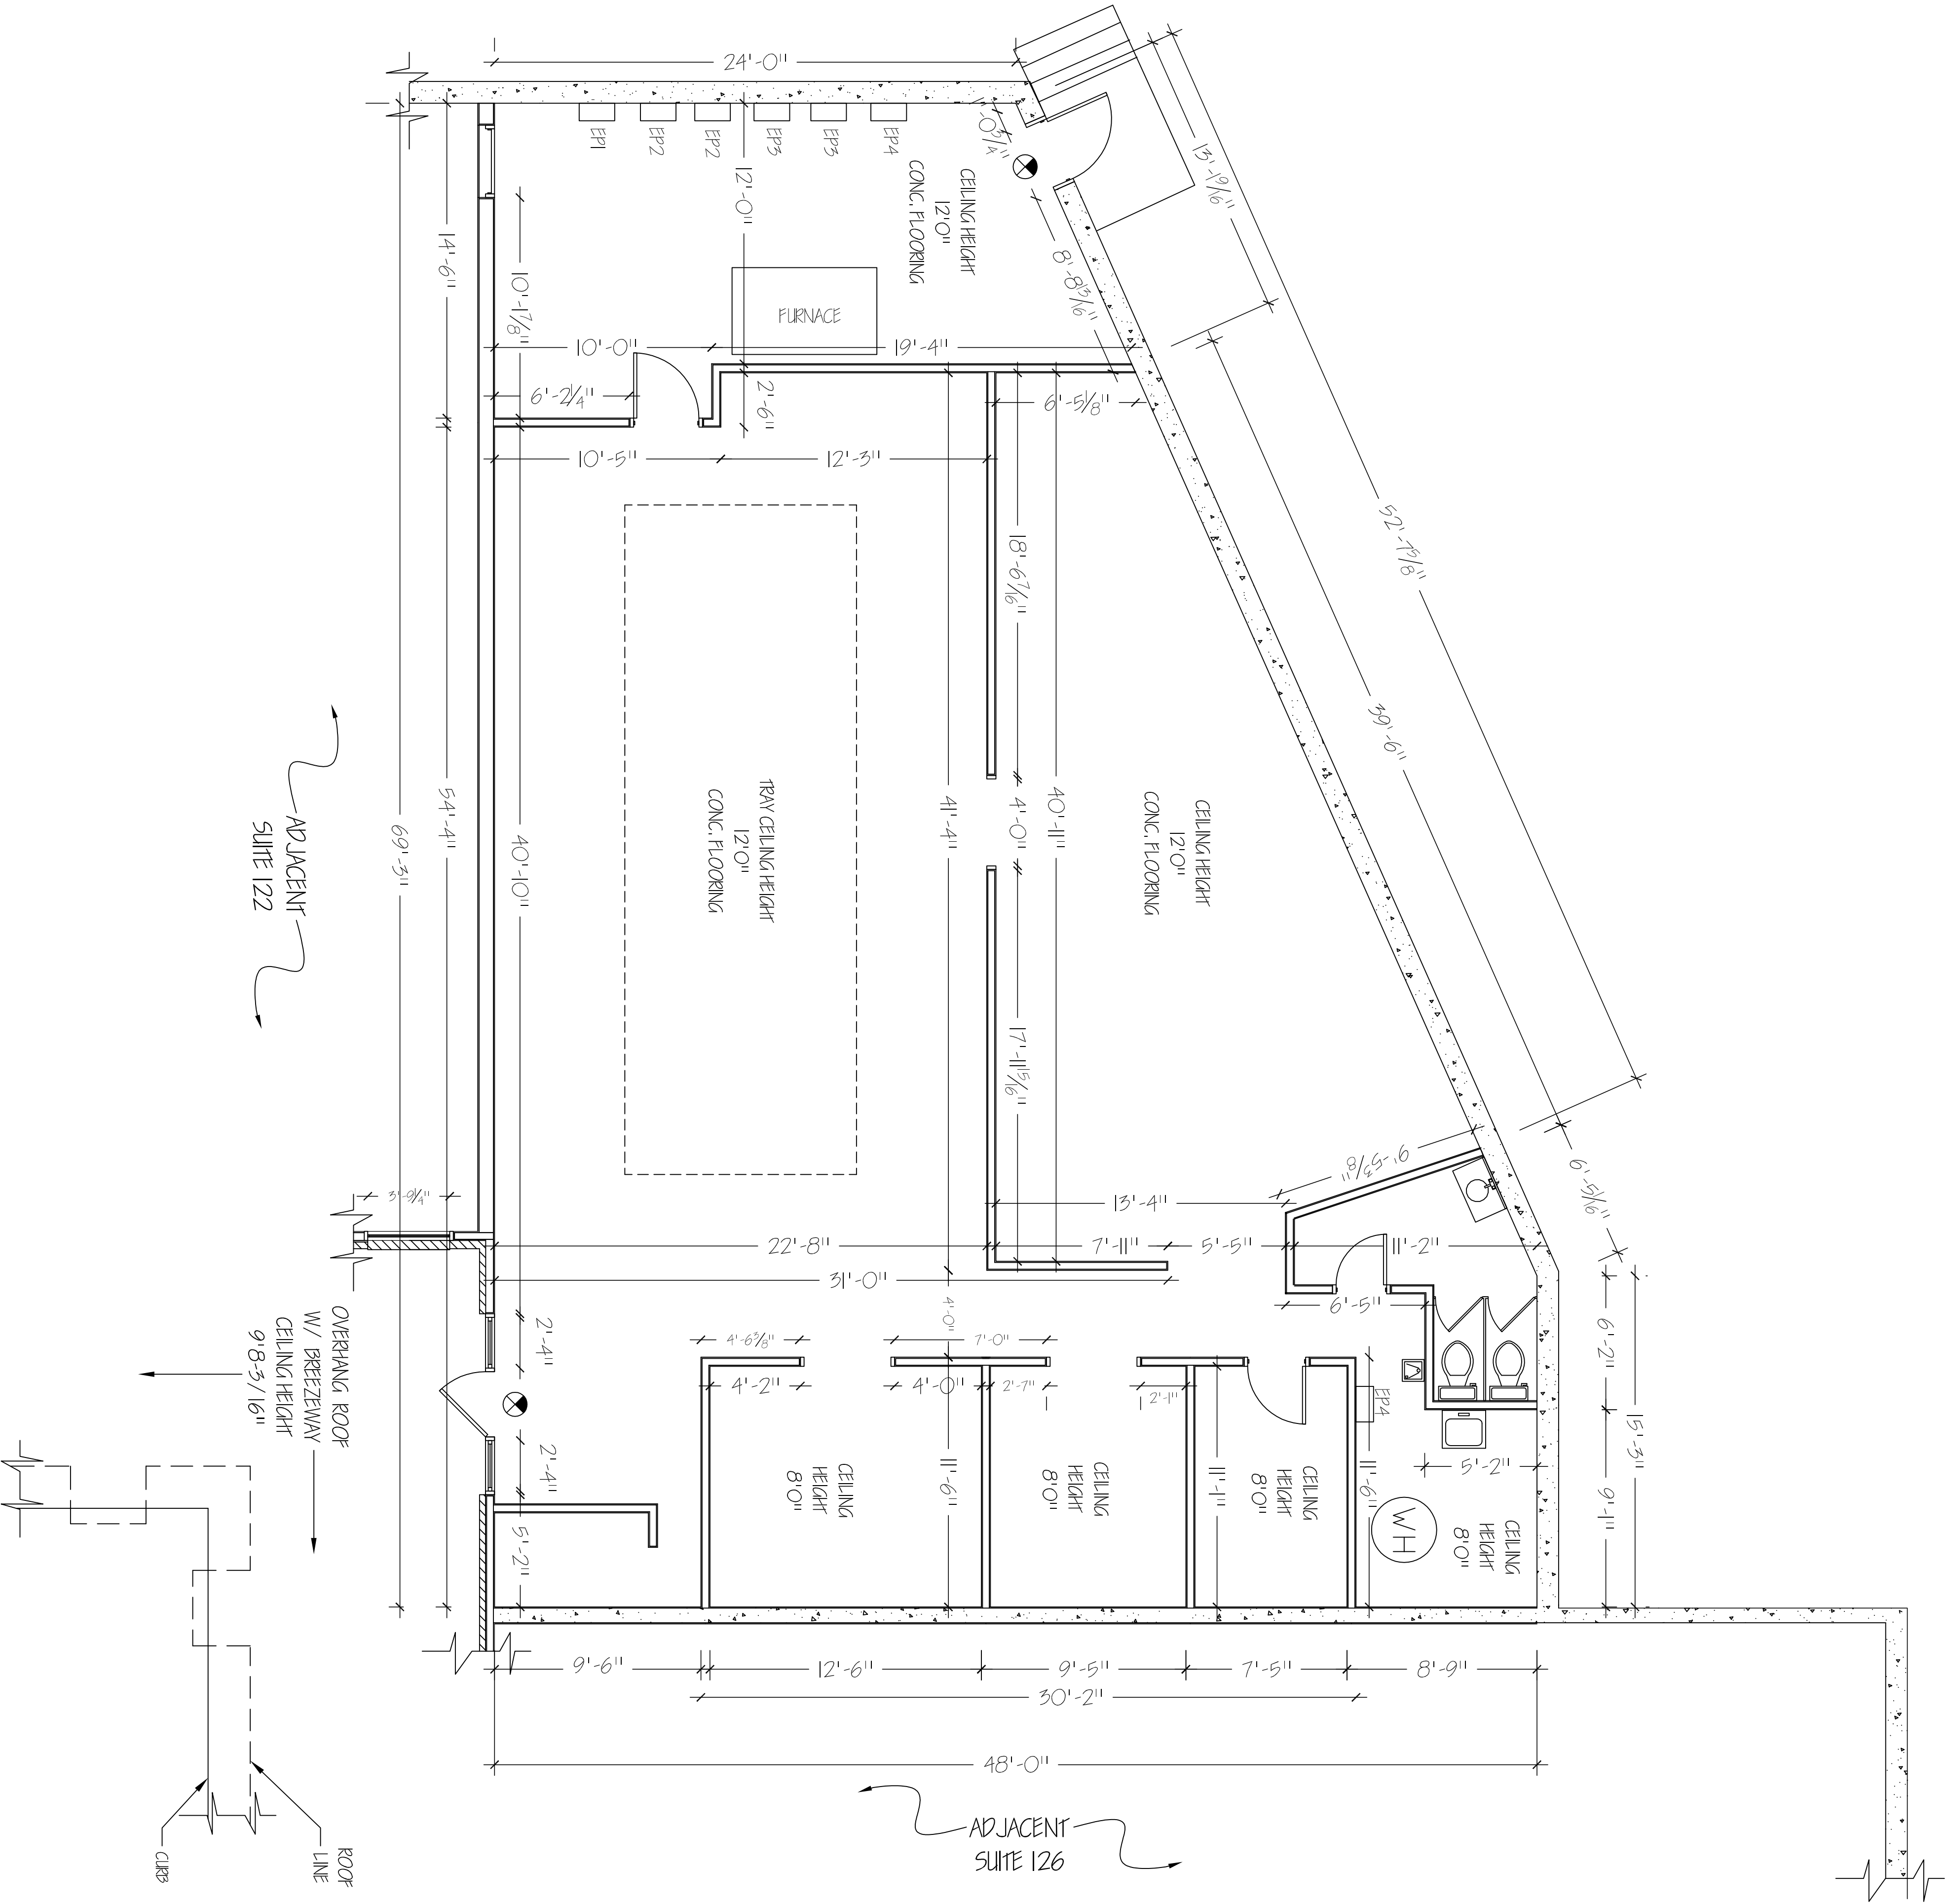

|            |            |
|------------|------------|
| DATE       | 11/23/2010 |
| DRAWN BY   | MMIMMS     |
| CHECKED BY | MMIMMS     |
| JOB NO.    | 11/23/2010 |
| SHEET      | 1          |

|                                                                                                                             |
|-----------------------------------------------------------------------------------------------------------------------------|
| FLOOR PLAN                                                                                                                  |
| ARCHITECTURAL ILLUSTRATION & DESIGN<br>507 TREE CORNERS PARKWAY<br>NORCROSS, GA 30092<br>770-364-7559 rengore2003@yahoo.com |

|                                                                                                     |
|-----------------------------------------------------------------------------------------------------|
| MARKET SQUARE SHOPPING CENTER<br>SUITE 124 UPDATE<br>102-180 MARKET SQUARE<br>CARTERVILLE, GA 30120 |
|-----------------------------------------------------------------------------------------------------|

|                                                                        |
|------------------------------------------------------------------------|
| MALON D MIMMS CO<br>85-A MILL ST.<br>ROSWELL, GA 30075<br>770-518-1100 |
|------------------------------------------------------------------------|

